


UTILITY LEGEND

- 23 — PROPOSED ODUT/PILE
- - - 23 - - - EXISTING CONTOUR
- ◇ PROPOSED UTILITY POLE
- P-OH PROPOSED OVERHEAD UTILITY LINE
- P-U/G PROPOSED UNDERGROUND UTILITY LINE
- PROPOSED TELCOM BOX
- PROPOSED TRANSFORMER
- ★ PROPOSED LIGHT
- PROPOSED POLE LIGHT
- P-F PROPOSED FUEL LINE
- P-O PROPOSED OXYGEN LINE
- W-I PROPOSED WATER INTAKE LINE
- W-D PROPOSED WATER DISCHARGE LINE
- FS PROPOSED FIRE SUPPRESSION LINE
- P-W PROPOSED DOMESTIC WATER LINE
- PROPOSED FIRE HYDRANT
- PROPOSED WATER DRILLED WELL
- PROPOSED UNDERDRAIN
- PROPOSED STORMWATER PIPE
- CB #7 PROPOSED STORMWATER CATCH BASIN
- P-S PROPOSED SANITARY GRAVITY LINE
- P-FM PROPOSED SANITARY FORCE MAIN
- PROPOSED SANITARY MANHOLE
- PROPOSED PUMP STATION

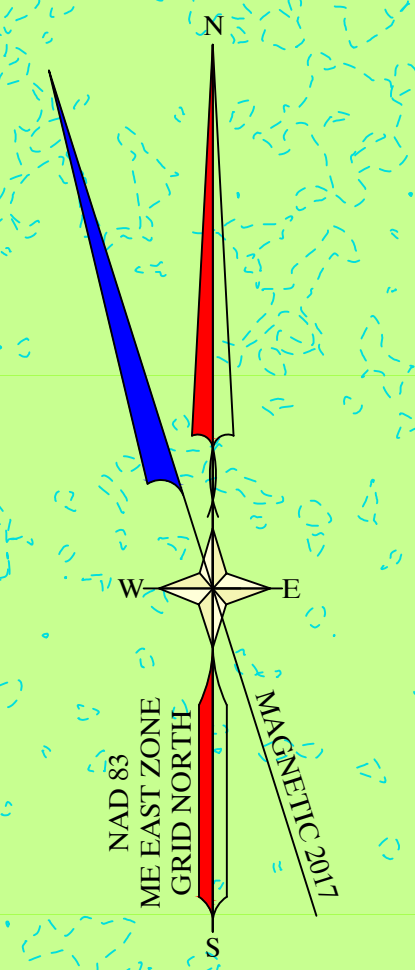

UTILITY PLAN	DATE: MARCH 25, 2021
SCALE: 1" = 50'	DRAWN BY: JAM
COUNTY: WASHINGTON	CHECKED BY: HTL
STATE: MAINE	NO.
TOWN: JONESPORT	REVISIONS
CLIENT PROJECT: KINGFISH MAINE	DATE
SHEET TITLE: UTILITY PLAN	NO.

Gartley & Dorsky
ENGINEERING SURVEYING

59 Union Street, Unit 1, P.O. Box 1031, Camden, ME 04843-1031
Ph: (207) 236-4365 Fax: (207) 236-3055 Toll Free: 1-888-282-4365
105 Main Street Suite 201, P.O. Box 1072, Damariscotta, Maine 04843
Ph: (207) 790-5405

PROJ. NO. 2019-412

C13

