


UTILITY LEGEND

	23	PROPOSED ODDUBLE
	23	EXISTING CONTOUR
		PROPOSED UTILITY POLE
	P-OH	PROPOSED OVERHEAD UTILITY LINE
	P-U/G	PROPOSED UNDERGROUND UTILITY LINE
		PROPOSED TELCOM BOX
		PROPOSED TRANSFORMER
		PROPOSED LIGHT
		PROPOSED POLE LIGHT
	P-F	PROPOSED FUEL LINE
	P-O	PROPOSED OXYGEN LINE
	W-I	PROPOSED WATER INTAKE LINE
	W-D	PROPOSED WATER DISCHARGE LINE
	F-S	PROPOSED FIRE SUPPRESSION LINE
	P-W	PROPOSED DOMESTIC WATER LINE
		PROPOSED FIRE HYDRANT
		PROPOSED WATER DRILLED WELL
		PROPOSED UNDERDRAIN
		PROPOSED STORMWATER PIPE
	CB #7	PROPOSED STORMWATER CATCH BASIN
	P-S	PROPOSED SANITARY GRAVITY LINE
	P-FM	PROPOSED SANITARY FORCE MAIN
		PROPOSED SANITARY MANHOLE
		PROPOSED PUMP STATION

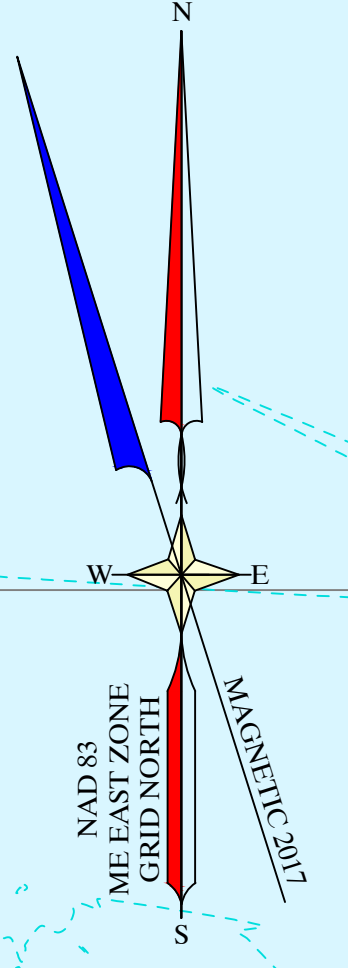

<p>UTILITY PLAN</p>	
<p>KINGFISH MAINE</p>	<p>WASHINGTON STATE, MAINE</p>
<p>DUN GARVIN ROAD</p>	<p>JONESPORT COUNTY</p>
<p>SCALE: 1" = 50'</p>	<p>DATE: MARCH 25, 2021</p>
<p>DRAWN BY: JAM</p>	<p>CHECKED BY: HTL</p>
<p>NO.</p>	<p>REVISIONS</p>
<p>DATE</p>	<p></p>

CLIENT/PROJECT: KINGFISH MAINE

LOCATION: DUN GARVIN ROAD

TOWN: JONESPORT COUNTY: WASHINGTON STATE, MAINE

DATE: MARCH 25, 2021

SCALE: 1" = 50'

DRAWN BY: JAM



CHECKED BY: HTL

NO.

REVISIONS

DATE

Gartley & Dorsky
 ENGINEERING SURVEYING
 59 Union Street, Unit 1, P.O. Box 1031, Camden, ME 04843-1031
 Ph: (207) 236-4365 Fax: (207) 236-3055 Toll Free: 1-888-282-4365
 105 Main Street Suite 201 P.O. Box 1072, Damariscotta, Maine 04843
 Ph: (207) 790-5405

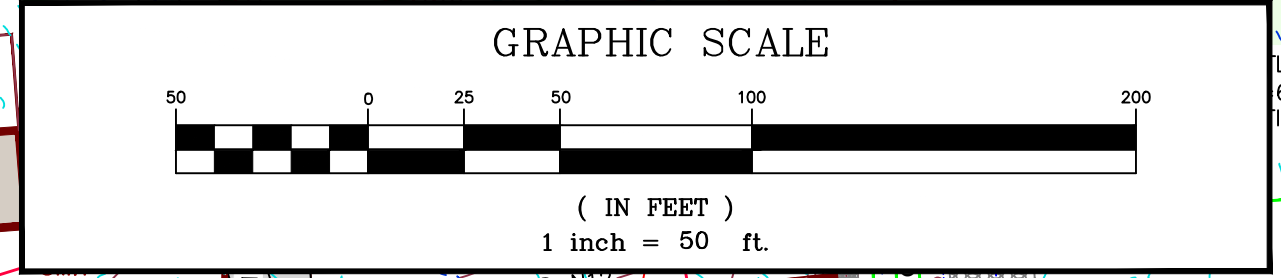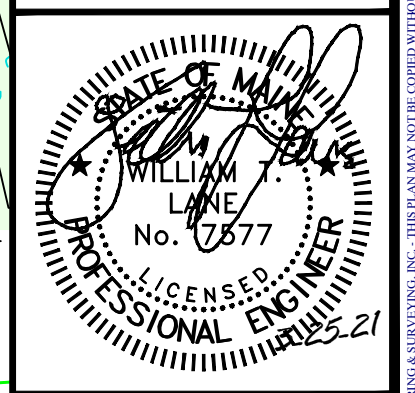

PROJ. NO. 2019-412

C14