
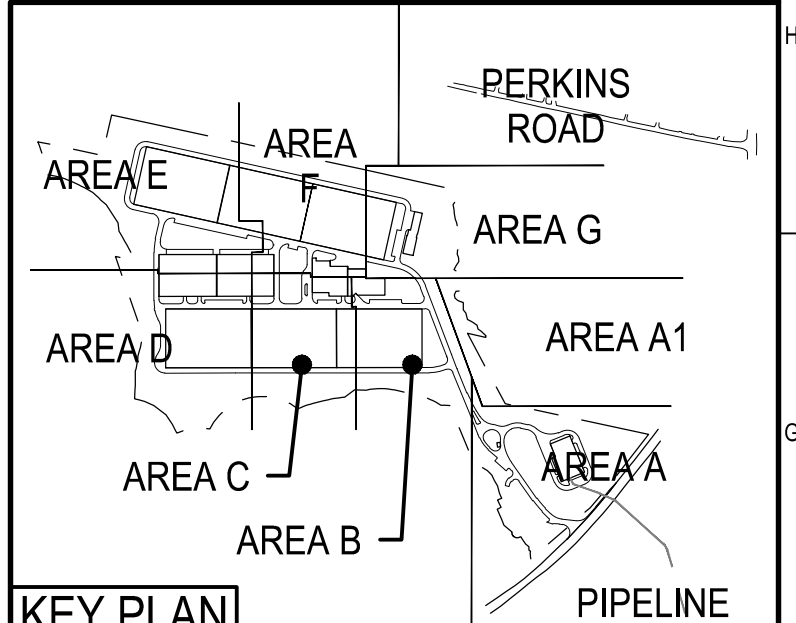


NOTE:
SEE CS- DRAWING SERIES FOR STORMWATER SYSTEM INFORMATION.

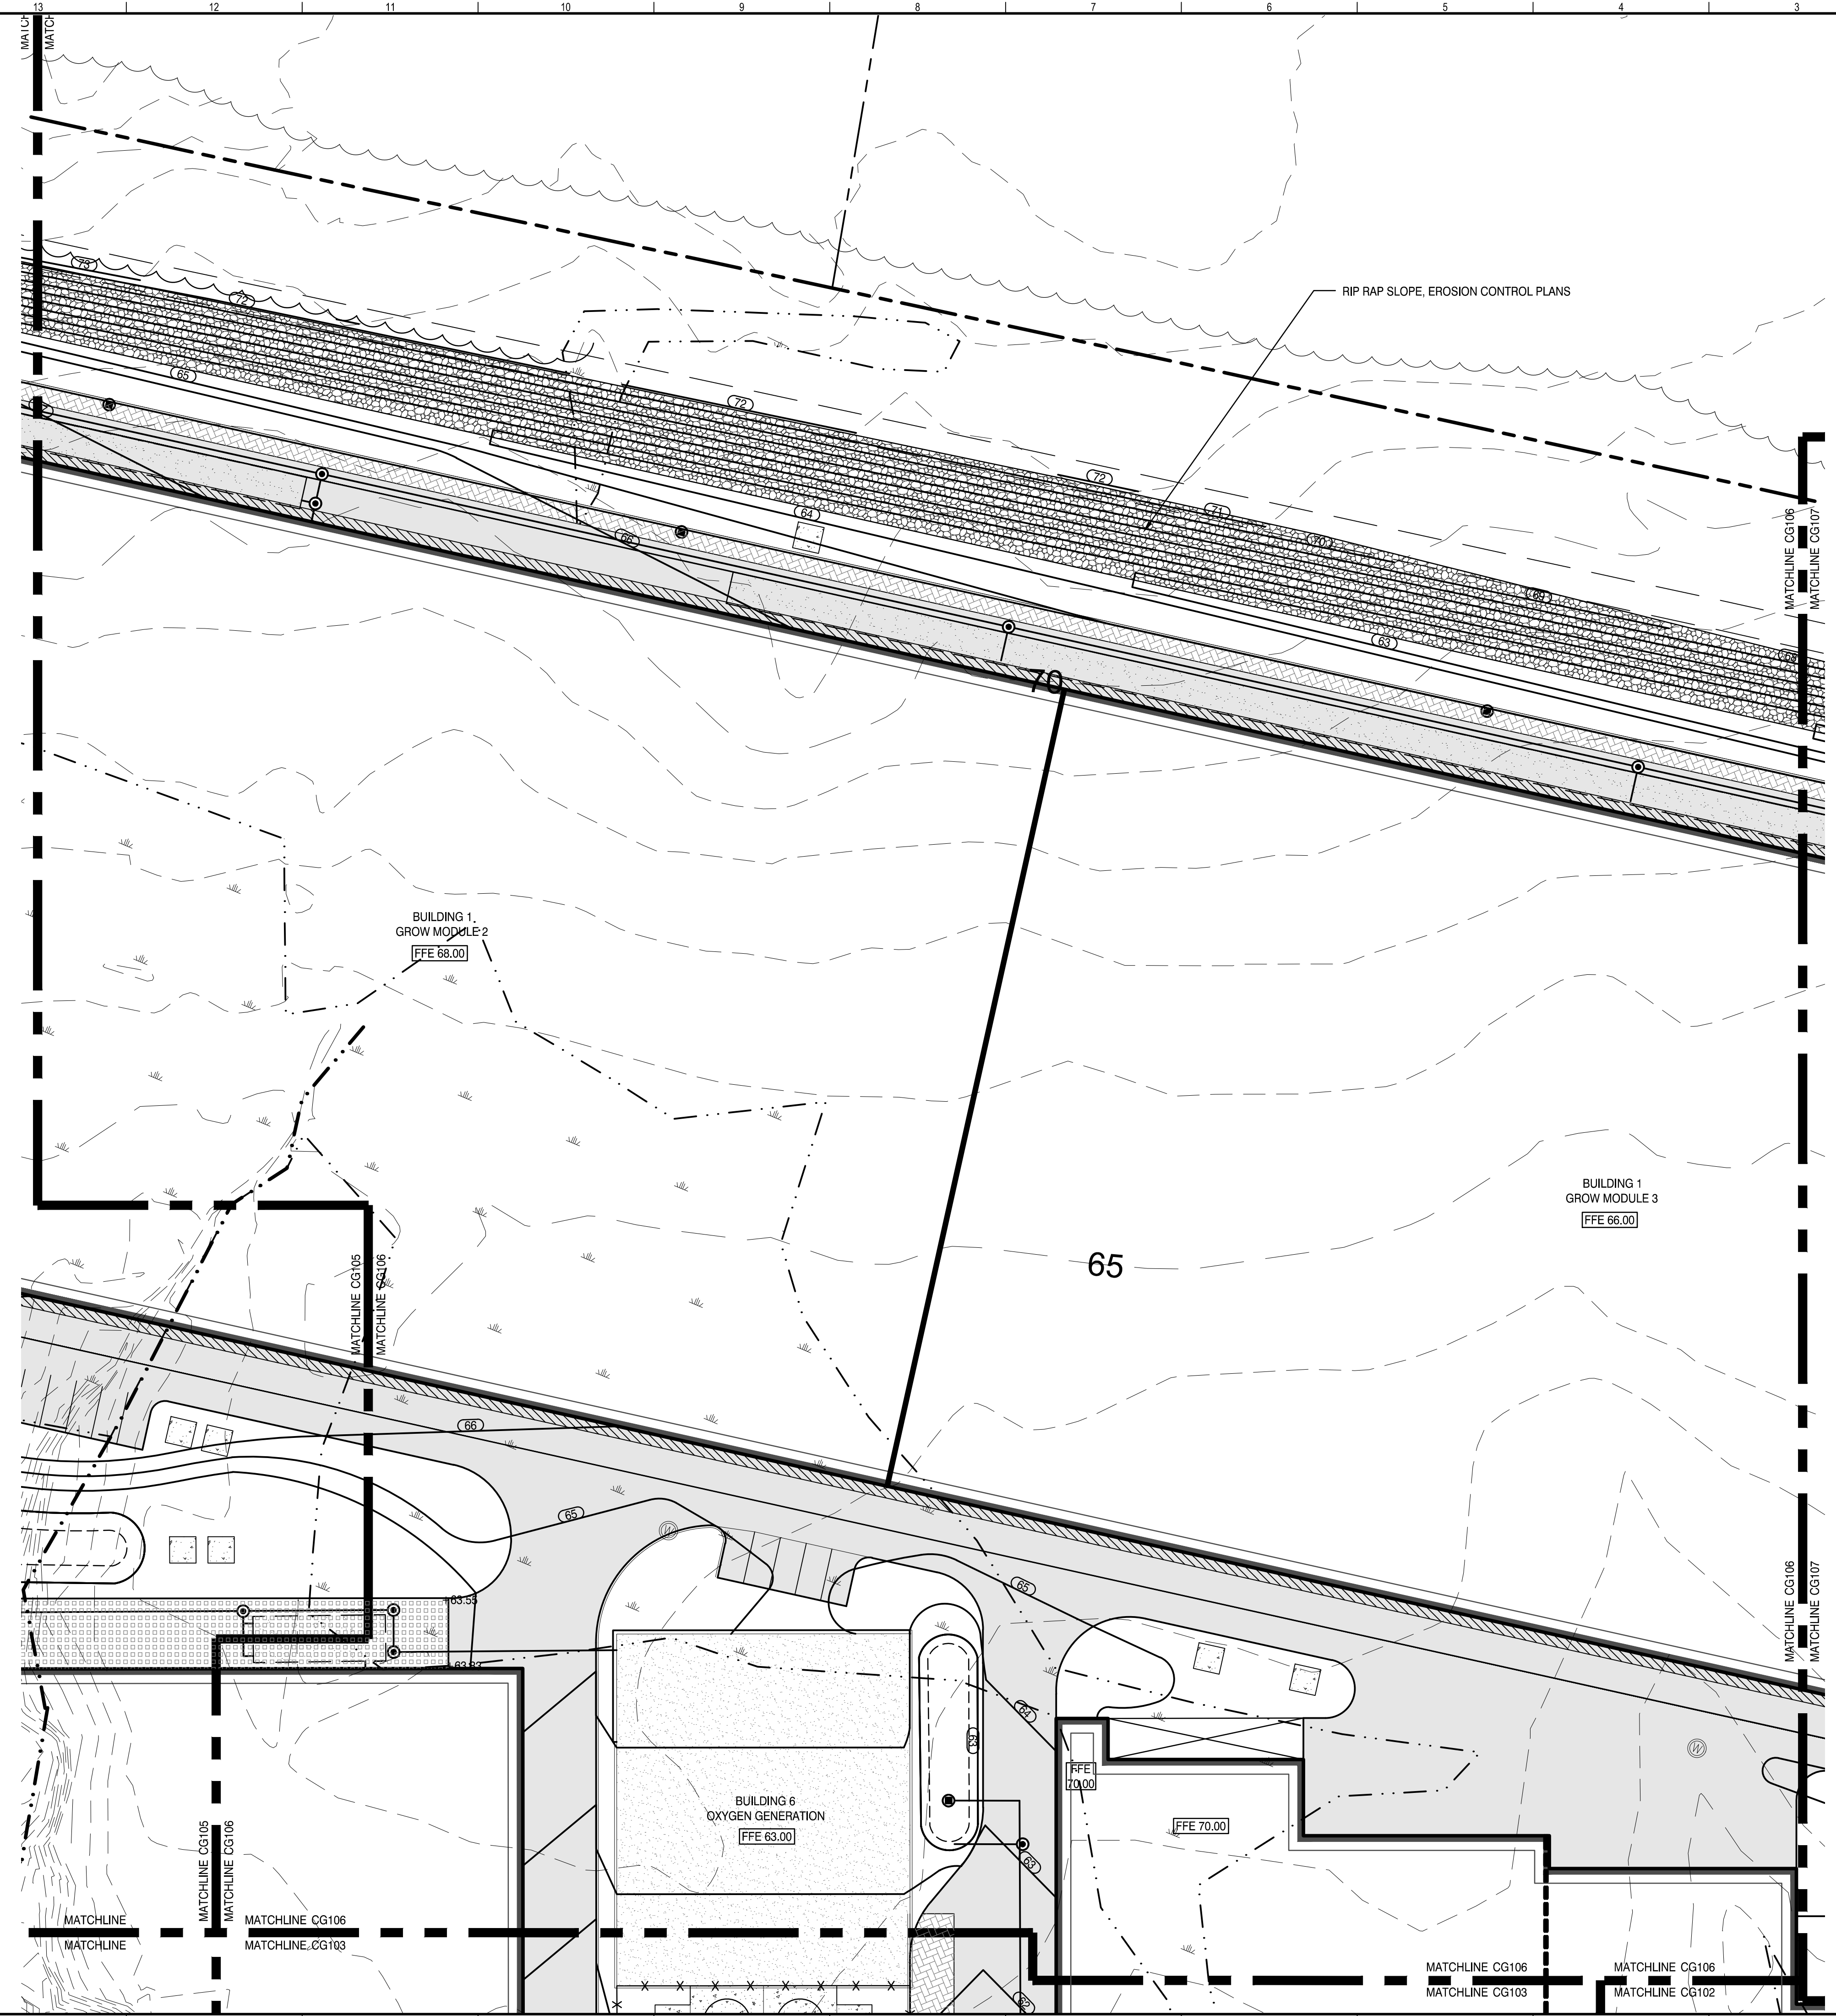

REV	DESCRIPTION	DATE

ISSUED FOR PERMIT

CURRENT ISSUE STATUS:

TRUE NORTH:


SMRT Architects and Engineers
144 Fore Street/P.O. BOX 618
Portland, Maine 04104
1.877.700.7678
www.smrtinc.com

ARCHITECTURE | ENGINEERING | PLANNING | INTERIORS | ENERGY

SMRT
RANSOM Consulting Engineers and Scientists
Ransom Consulting Engineers and Scientists
400 Commercial Street, Suite 400
Portland, Maine 04101

NORDIC AQUAFARMS
285 NORTHPORT AVENUE
BELFAST, MAINE

GRADING PLAN
AREA F

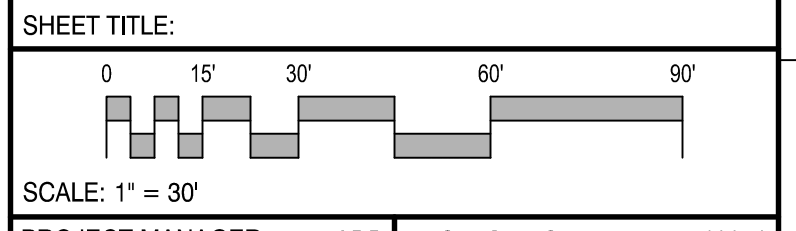

PROJECT MANAGER: ADB PROJECT NO: 18076
A/E OF RECORD:
JOB CAPTAIN: SP
DRAWN BY: WSM
SMRT FILE: CG106-18076 SHEET No. CG106

NOT FOR CONSTRUCTION